


Luminaire Schedule					
Symbol	Qty	Label	Arrangement	Total Lamp Lumens	LLF
	16	S1500_NEMA5 V0_0A	SINGLE	200000	0.950

Calculation Summary							
Label	CalcType	Units	Avg	Max	Min	Avg/Min	Max/Min
Soccer #02	Illuminance	Fc	20.97	26.9	11.8	1.78	2.28


Luminaire Location Summary						
LumNo	Label	X	Y	Z	Orient	Tilt
1	S1500_NEMA5 V0_0A	135	85	60	148.201	62.961
2	S1500_NEMA5 V0_0A	-135	85	60	31.799	62.961
3	S1500_NEMA5 V0_0A	135	-85	60	211.799	62.961
4	S1500_NEMA5 V0_0A	-135	-85	60	328.201	62.961
5	S1500_NEMA5 V0_0A	135	85	60	203.962	67.882
6	S1500_NEMA5 V0_0A	-135	85	60	336.038	67.882
7	S1500_NEMA5 V0_0A	135	-85	60	156.038	67.882
8	S1500_NEMA5 V0_0A	-135	-85	60	23.962	67.882
9	S1500_NEMA5 V0_0A	135	85	60	233.374	66.905
10	S1500_NEMA5 V0_0A	-135	85	60	306.626	66.905
11	S1500_NEMA5 V0_0A	135	-85	60	126.626	66.905
12	S1500_NEMA5 V0_0A	-135	-85	60	53.374	66.905
13	S1500_NEMA5 V0_0A	135	85	60	171.093	66.121
14	S1500_NEMA5 V0_0A	-135	85	60	8.907	66.121
15	S1500_NEMA5 V0_0A	135	-85	60	188.907	66.121
16	S1500_NEMA5 V0_0A	-135	-85	60	351.093	66.121

#	Date	Comments

#	Date	Comments

Drawn By:	Checked By:	Date: 2016/10/20	Scale:
-----------	-------------	------------------	--------

Soccer - Generic

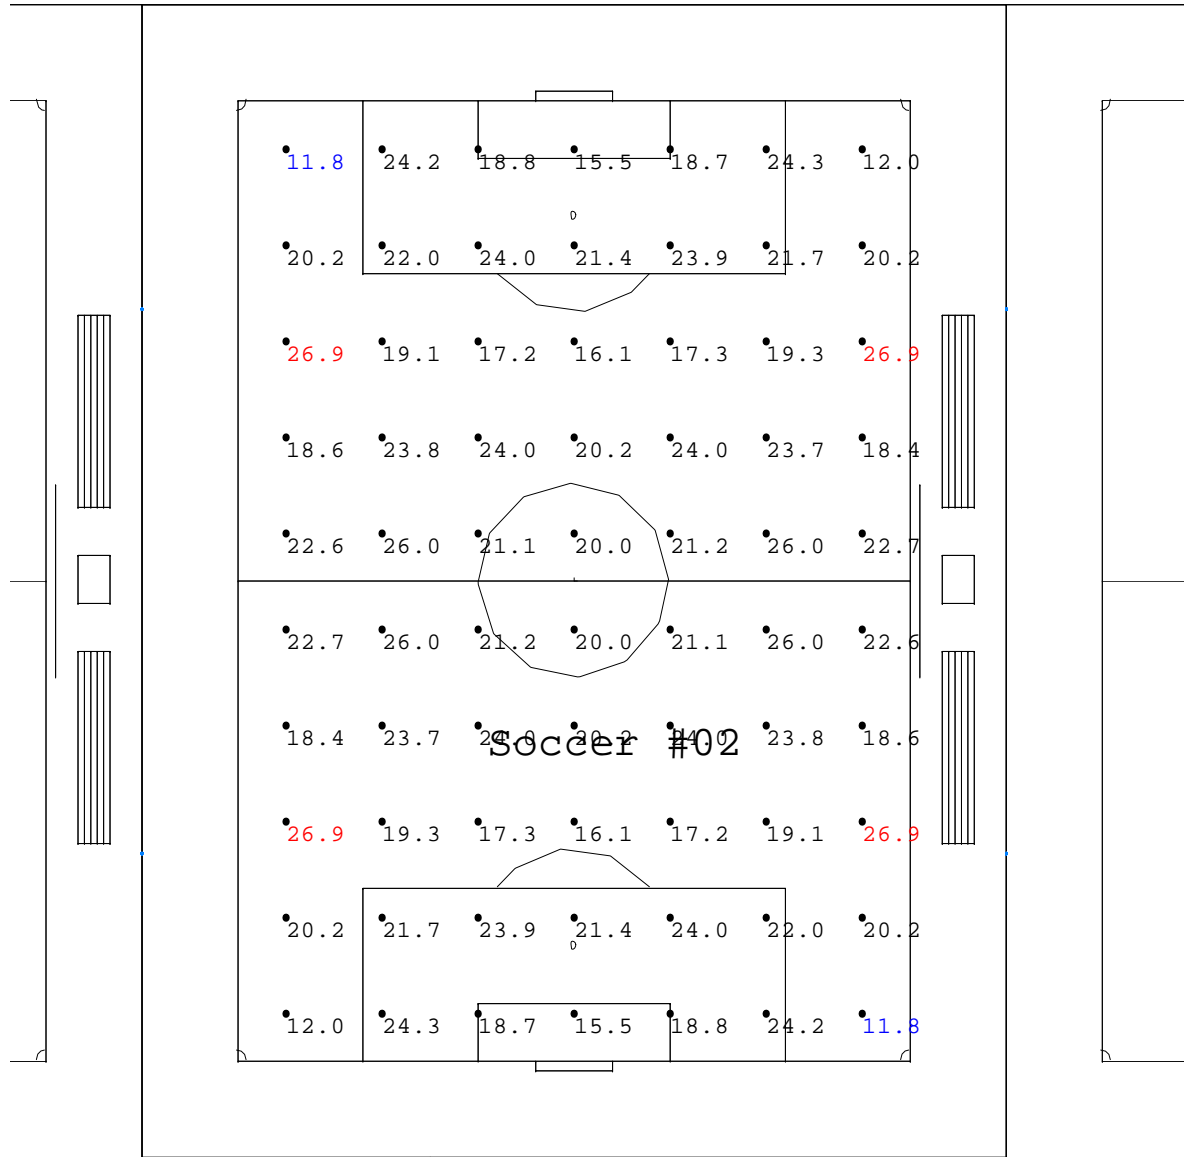


Calculation Summary							
Label	CalcType	Units	Avg	Max	Min	Avg/Min	Max/Min
Soccer #02	Illuminance	Fc	20.97	26.9	11.8	1.78	2.28

#	Date	Comments


#	Date	Comments

Drawn By:	Checked By:	Date: 2016/10/20	Scale: 1:40
-----------	-------------	------------------	-------------

Soccer - Generic

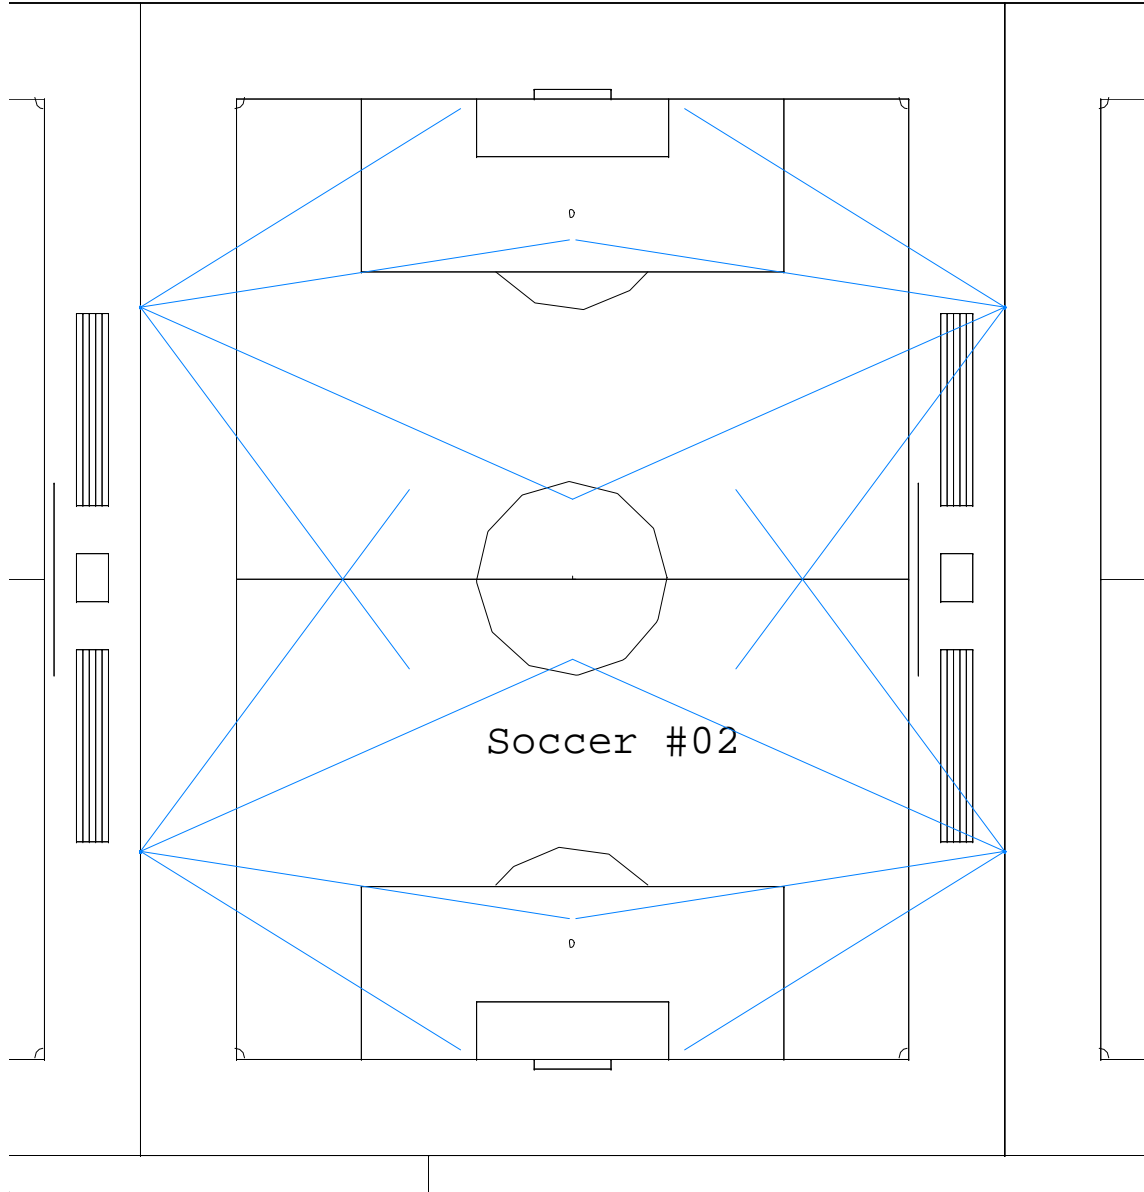

Soccer #02

Luminaire Schedule					
Symbol	Qty	Label	Arrangement	Total Lamp Lumens	LLF
	16	S1500_NEMA5 V0_0A	SINGLE	200000	0.950

SPORTSBEAMS
LIGHTING UP THE SPORTS WORLD

#	Date	Comments			
Revisions					
Drawn By:	Checked By:	Date: 2016/10/20		Scale: 1:40	
Soccer - Generic					
Page 3 of 3					